


I.D.A.

HOUSING & URBAN PROJECTS
DRG DATE: 11/7/54

DOA-574

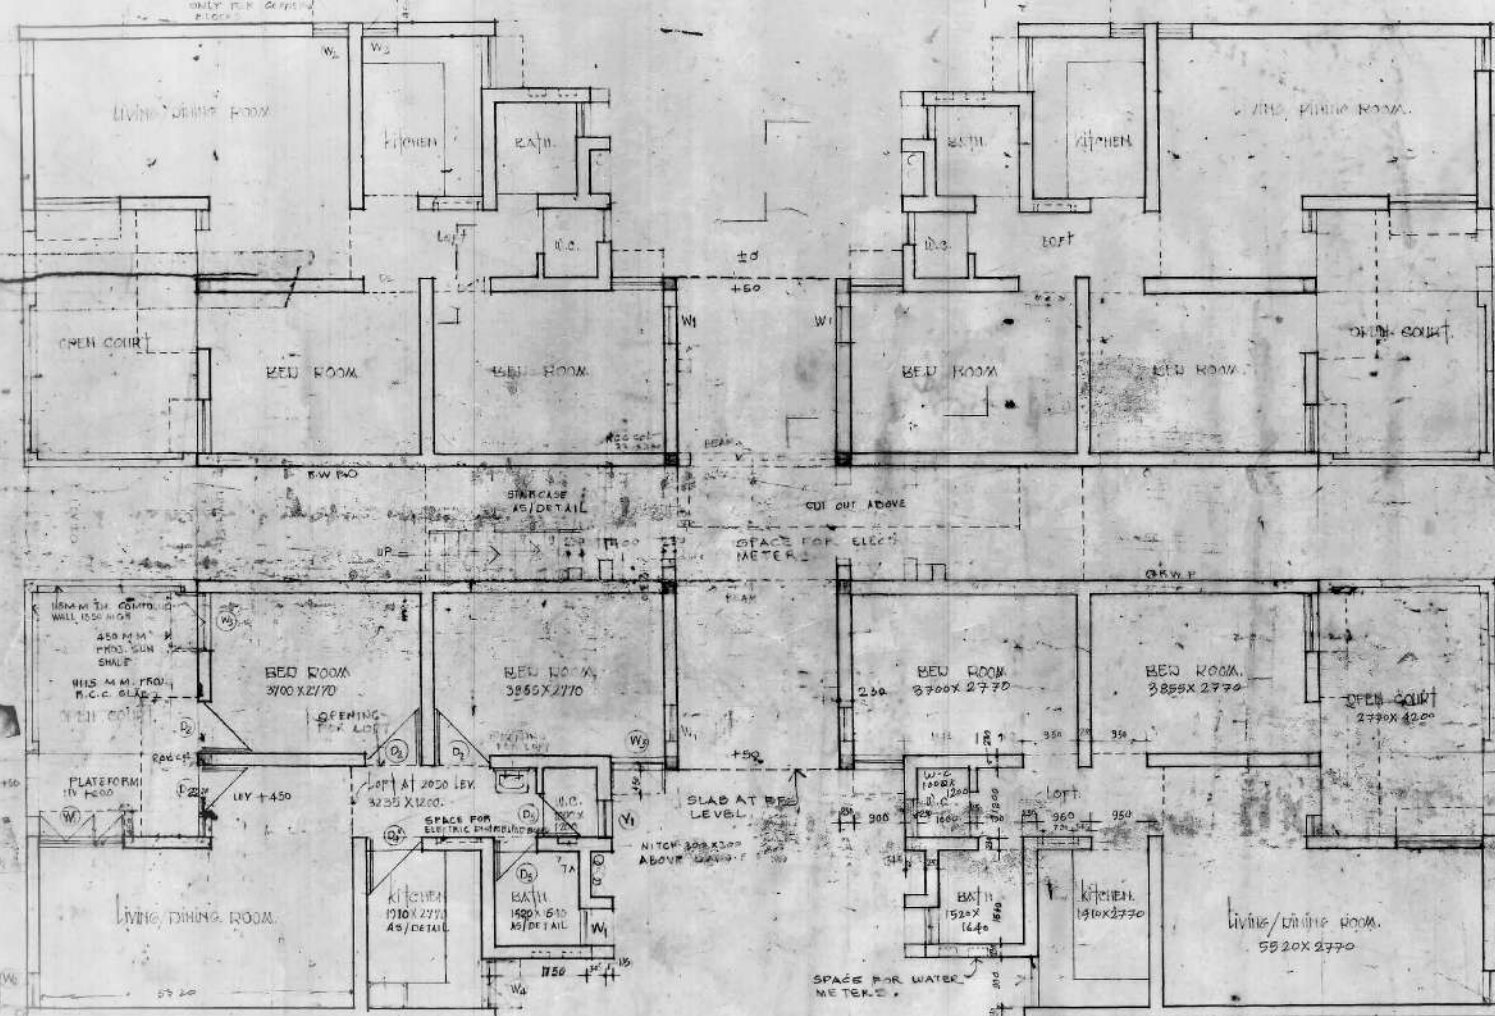

NOTE:
THE CHANGES, SUCH AS:
1. WINDOW IN G-FLOOR BED ROOM TO BE ADDED.
2. F. FLOOR ST. CASE REDUCED BY 300 MM.
3. T. FLOOR BALCONY INCREASED BY 850 MM.
HAVE BEEN DONE AS DECIDED IN THE EXPERT COMMITTEE MEET'G HELD ON 24-11-53.

AREA STATEMENT:

BOND AREA NEW UNIT AT G.F.	64.10 SQ.M.
BOND AREA AT G.F. LEVEL	4.70
TOTAL BOND AREA AT G.F.	68.80
BOND AREA NEW UNIT AT 1 ST F.	58.78
BOND AREA AT 1 ST F. LEVEL	4.70
TOTAL BOND AREA AT 1 ST F.	64.48
BOND AREA NEW UNIT AT 2 ND F.	47.97
BOND AREA AT 2 ND F. LEVEL	4
TOTAL BOND AREA AT 2 ND F.	51.97
BOND AREA NEW UNIT AT 3 RD F.	47.97
BOND AREA AT 3 RD F. LEVEL	4
TOTAL BOND AREA AT 3 RD F.	51.97

OPENING FOR LOFT IN BED ROOM TO BE CHANGED FROM 10' 0" TO 11' 0" AS DECIDED BY EXP. COMMITTEE.

SCHEDULE OF DOORS & WINDOWS

S.NO.	TYPE	SIZE	DESCRIPTION
1.	D ₁	2500 X 1200	PANELLED DOOR
2.	D ₂	750 X 1200	PAINTED DOOR
3.	D ₃	1500 X 1500	PAINTED DOOR WITH GLASS
4.	D ₄	1200 X 1200	PAINTED DOOR WITH GLASS
5.	W ₁	600 X 950	GLAZED WINDOW
6.	W ₂	600 X 1200	GLAZED WINDOW
7.	W ₃	900 X 1200	GLAZED WINDOW
8.	W ₄	900 X 1000	GLAZED WINDOW
9.	W ₅	1200 X 1200	GLAZED WINDOW
10.	V ₁	600 X 600	VENTILATOR
11.	W	1500 X 1200	GLAZED WINDOW

- CONTENTS OF DRS:**
1. GROUND FLOOR PLAN
 2. FIRST FLOOR PLAN
 3. SECOND FLOOR PLAN
 4. THIRD FLOOR PLAN
 5. ELECTRICAL PLAN
 6. ELEVATION
 7. SECTION
 8. DETAIL
 9. DETAIL
 10. DETAIL
 11. DETAIL
 12. DETAIL
 13. DETAIL
 14. DETAIL
 15. DETAIL

POSITION OF ELECTRIC METER SHALL BE CHANGED FROM PRESENT POSITION TO NEW POSITION AS DECIDED BY EXP. ELECT. COMMITTEE. NO. OF ELECT. CIRCUITS TO BE 10. WATER METER SHALL BE 1/2" B.P.

STANDARD DESIGN FOR HOUSING PROJECTS
GROUND FLOOR PLAN 102

102


I.D.A.

HOUSING & URBAN
PROJECTS DIV.

DATED - 1/2/53

AREA STATEMENT:

COVD. AREA PER UNIT AT F.F. = 53.76 SQM
COVD. AREA OF STAIRCASE = 4.70
TOTAL COVD. AREA AT F.F. = 58.46

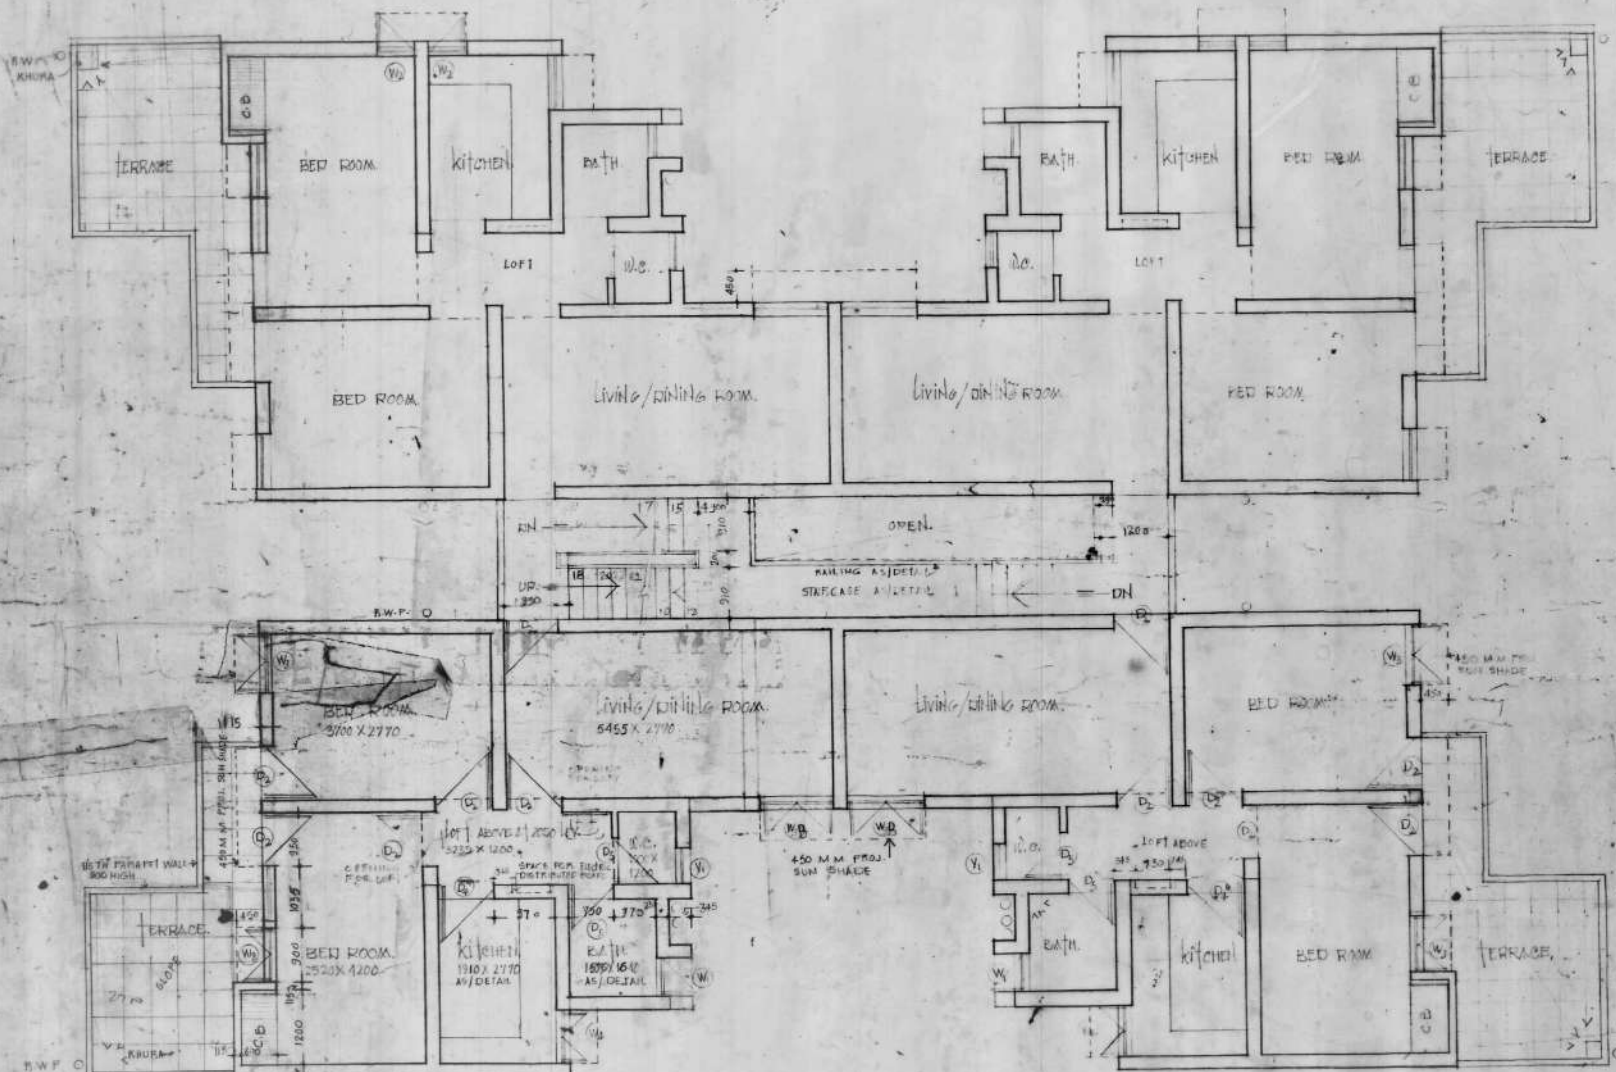

STANDARD DESIGN FOR
M.I.G. HOUSING

FIRST FLOOR
PLAN


192

NO. 192

SCHEME NO. 192

ARCH. DESIGNED BY ARCH. DRAWN BY ARCH. CHECKED BY

ARCH. DESIGNED BY ARCH. DRAWN BY ARCH. CHECKED BY

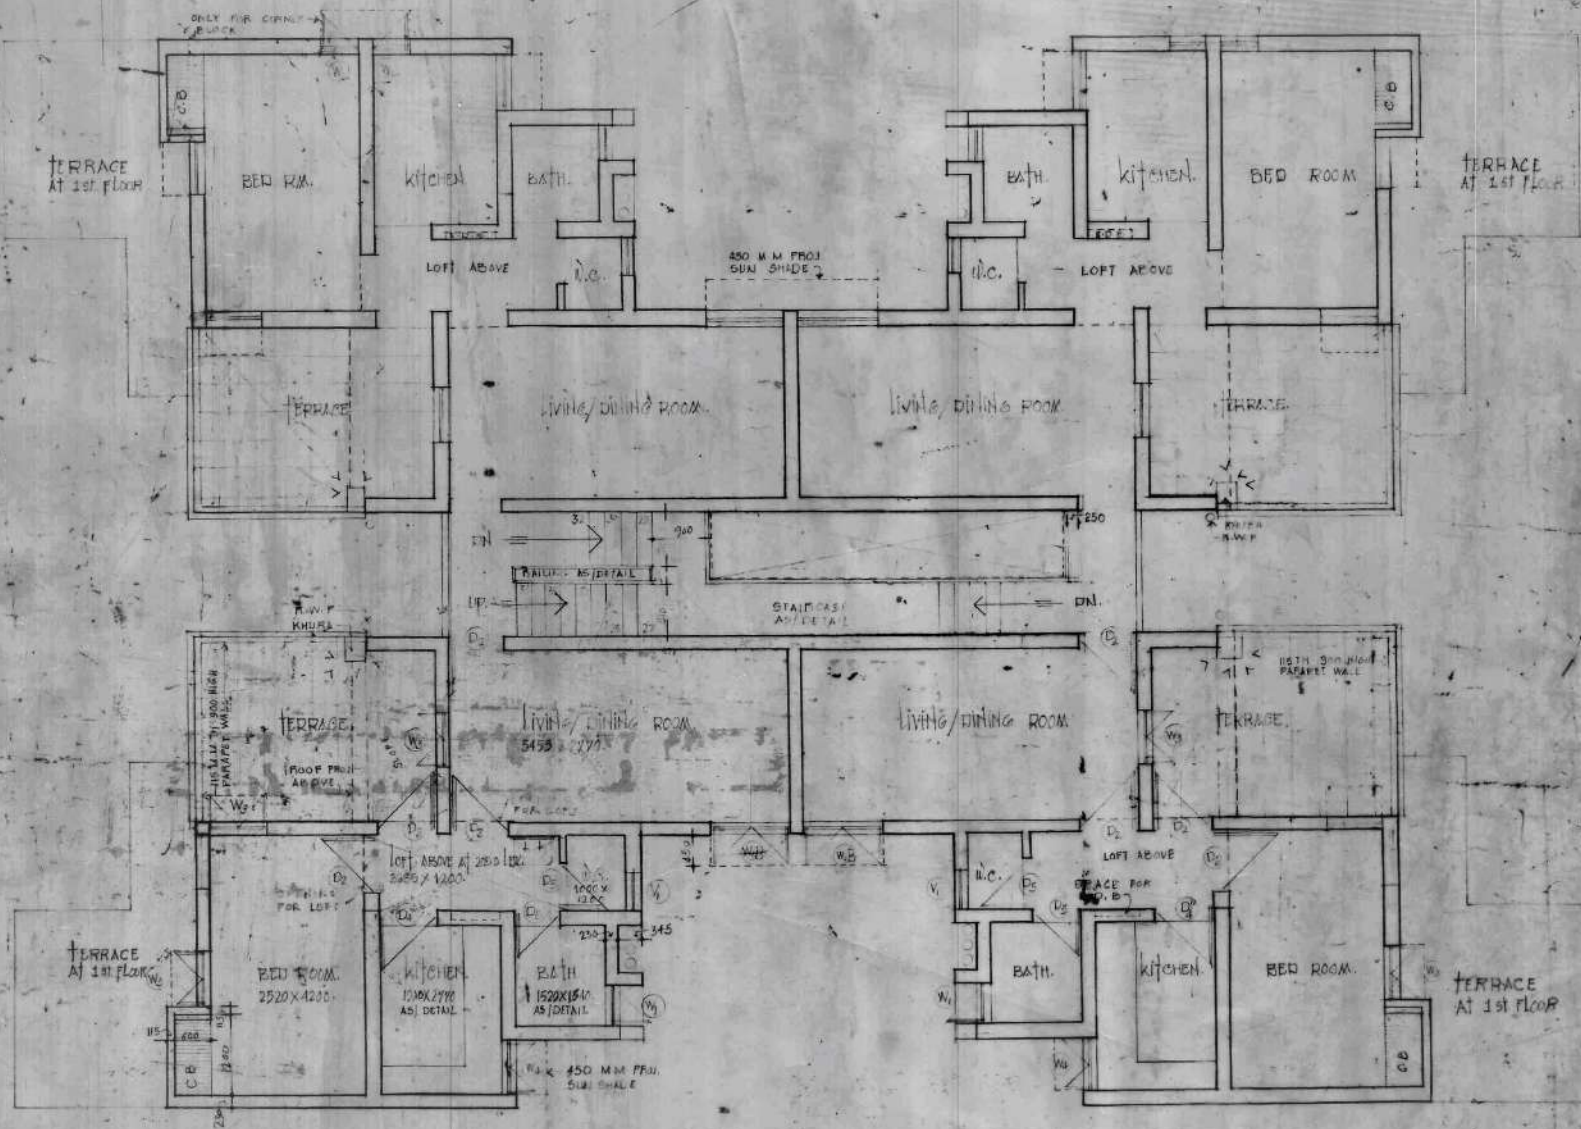

HOUSING
- DATED

AREA STATEMENTS:
COVER AREA PER UNIT AT 2ND F. = 47.97 SQ. M.
COVER AREA - STAIRS E. = 4.70
TOTAL COVER AREA AT 2ND F. = 52.67

FOR OFFICE USE

STANDARD DESIGN FOR
M.T.G. HOUSING
M.V. PH. II - PRT. IV

SECOND FLOOR 192
PLAN.

SCALE 1:50
3
ARCH. D/MAN ARCH. ARCHT. ARCHITECT
SR. ARCHITECT AD. CHIEF ARCH. CHIEF ARCH.

DDA-517


D.D.A.

HOUSING & URBAN
PROJECTS WING.

DATED - 6/8/87

AREA STATEMENTS:

- COVERED AREA PER UNIT AT 1st F. = 47.21 SQ.M.
- COVERED AREA AT STAIRCASE = 4.70
- TOTAL COVERED AREA AT 1st F. = 52.57

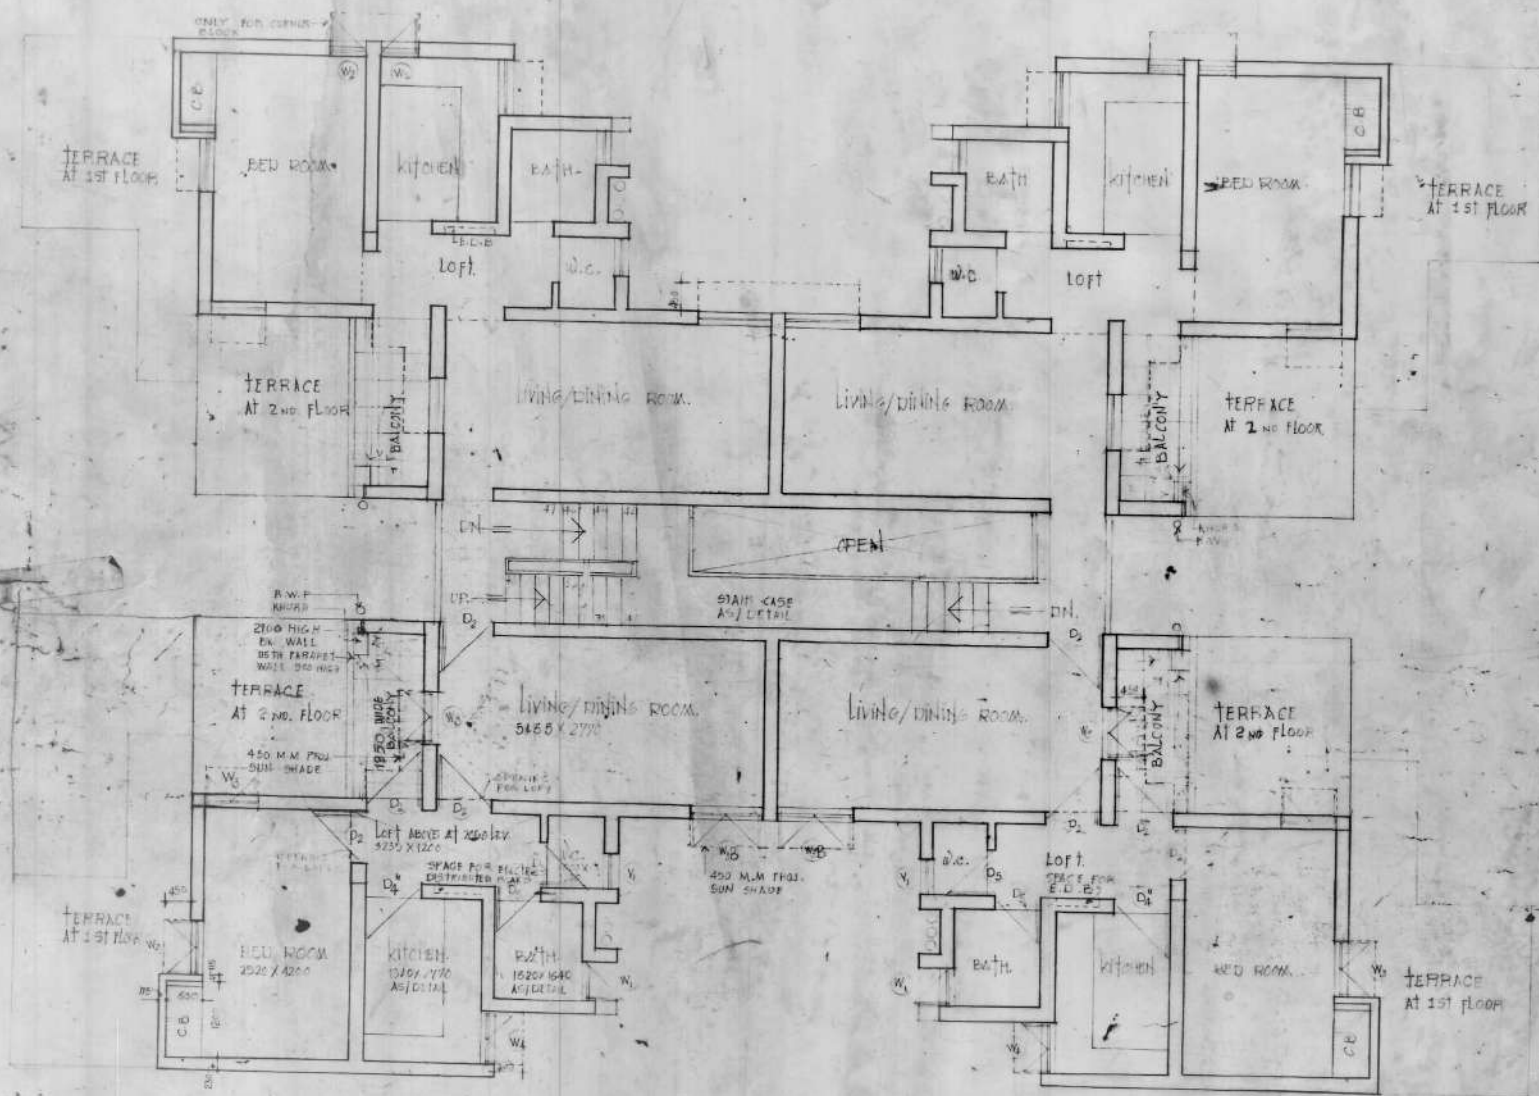

STANDARD DESIGN FOR
M.I.G. HOUSING
M.V. PH-II - PKT


THIRD FLOOR PLAN 192
SCALE - 1/50
SCHEME NO. SHEET NO.

DR. ARCHITECT	MR. CHIEF ARCH.	CHIEF ARCH.
K. Ravi		L. S. S. S.

I.D.A.

HOUSING & URBAN PROJECTS WING

DATE 7 / 8 / 87

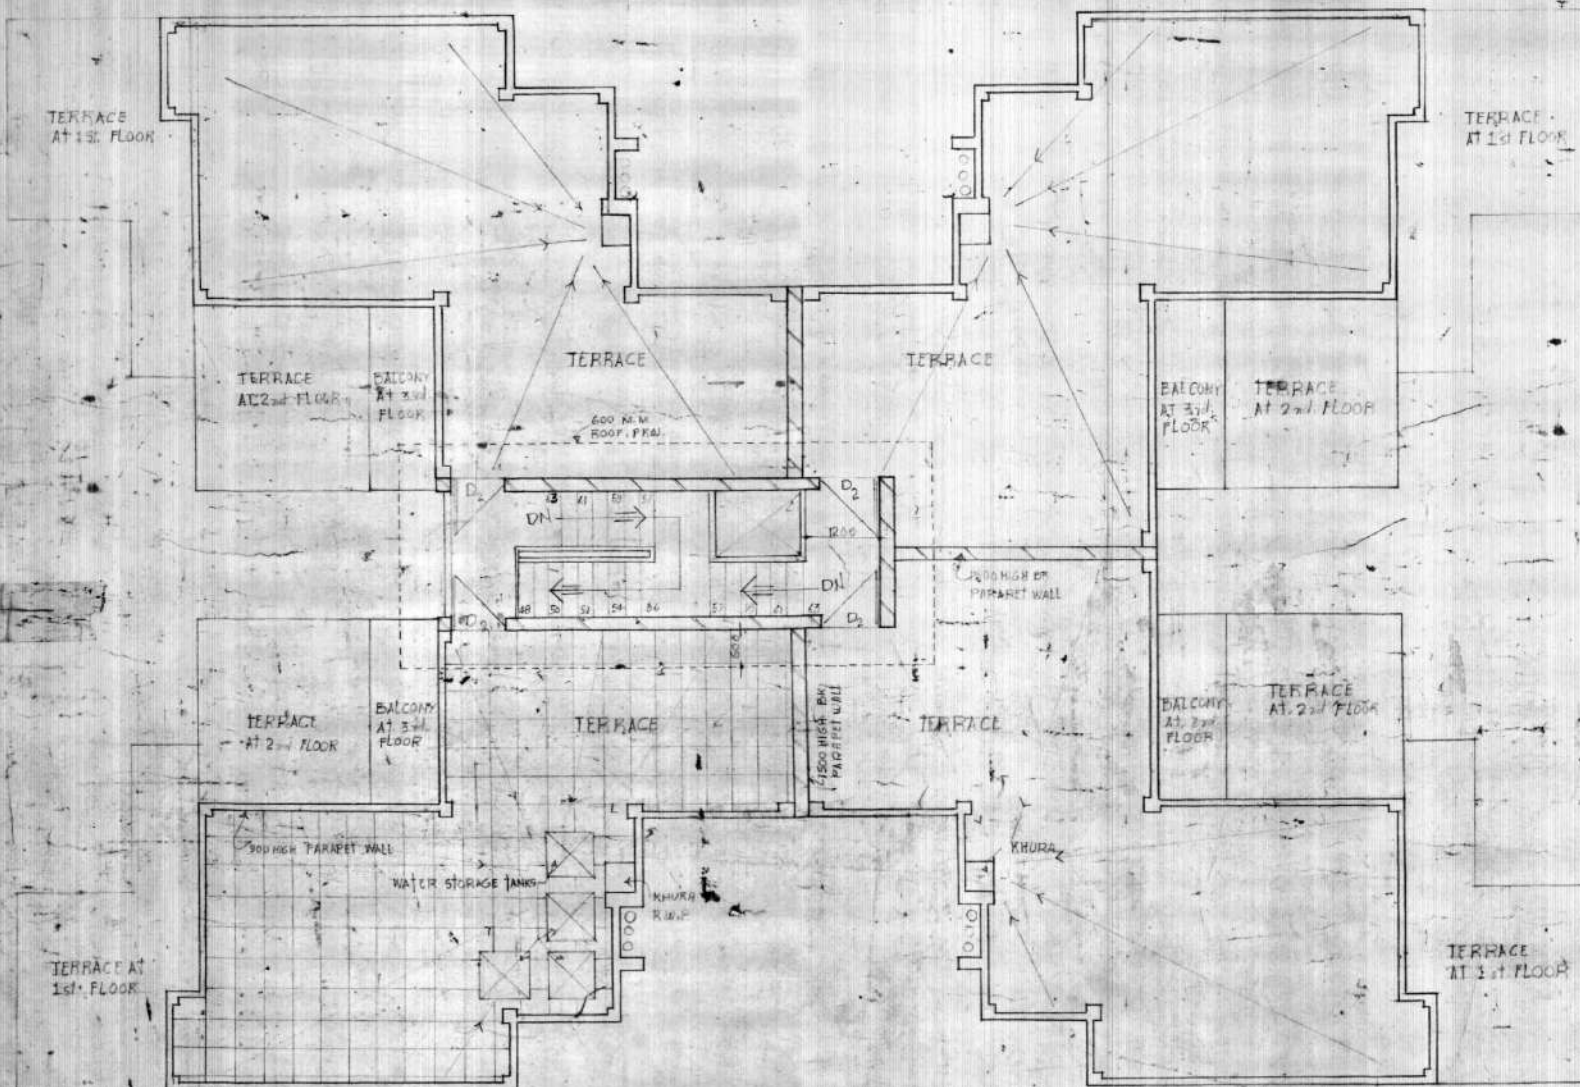

STANDARD DESIGN FOR
M.I.G. HOUSING


TERRACE PLAN 192
SCHEME SHEET 5

ARCH. D/MAN	ARCH. ARCH.	ARCH. ARCH.
K. K.		
S.R. ARCHITECT	ARCH. ARCH.	

D. D. A.

HOUSING & URBAN PROJECTS DIV.

DATE 10/8/51

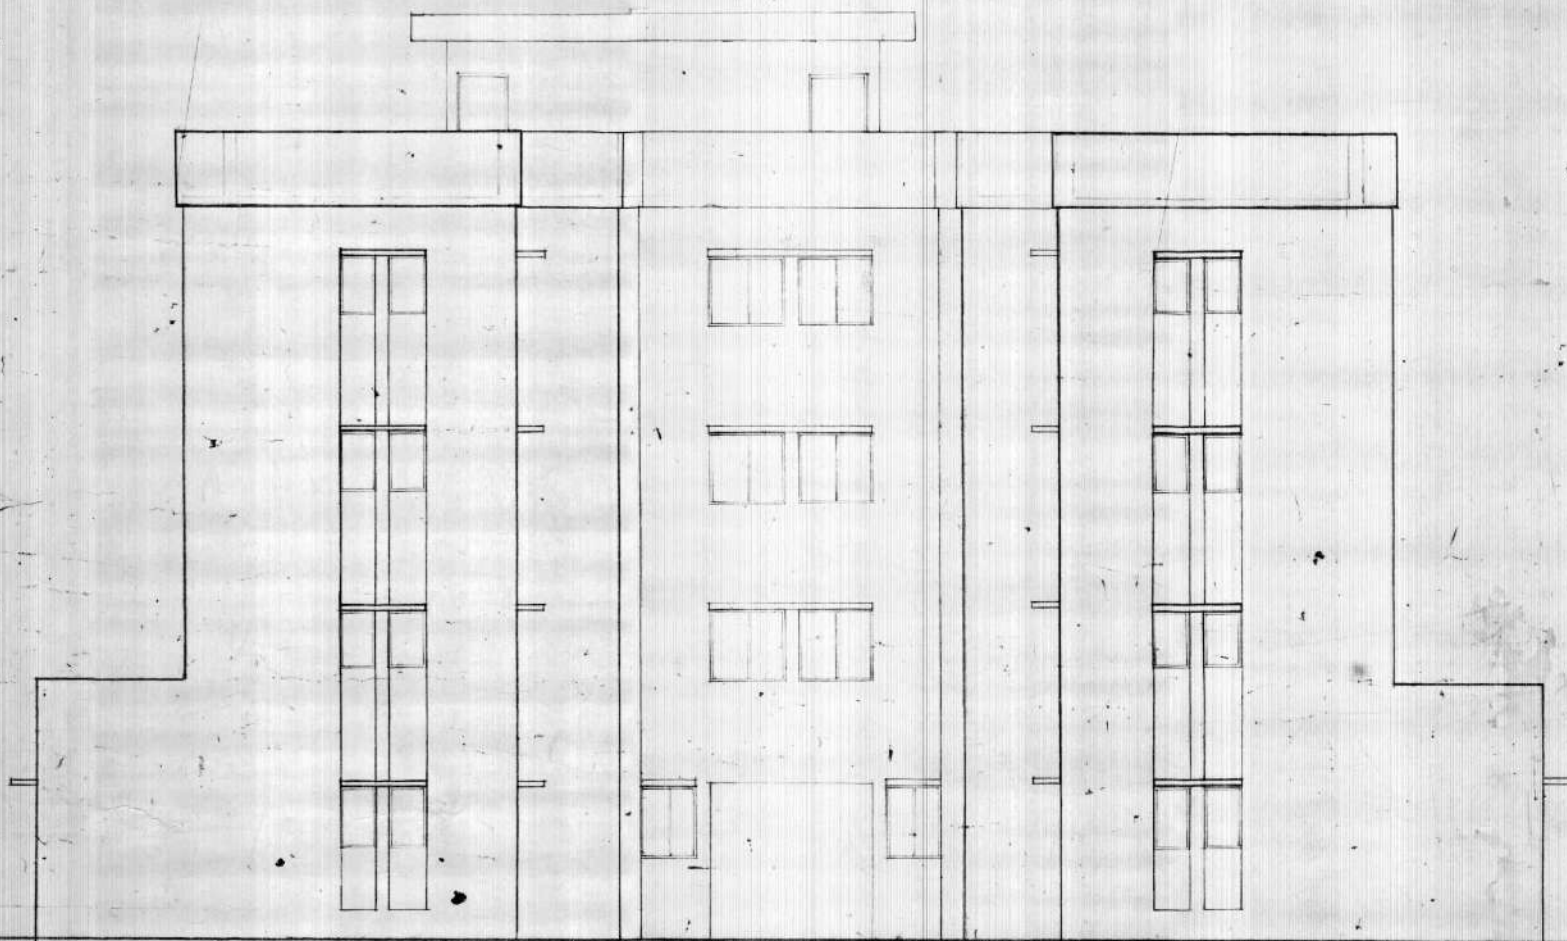

SIDE ELEVATION

FOR OFFICE USE

D. D. A.

STANDARD DESIGN FOR
M.I.G. HOUSING


ELEVATION 192
SCALE 1/8" = 1'-0"

ARCHITECT D. D. A. ARCHITECT


DATE 10/8/51

BY ARCHITECT D. D. A.

DATE 26/5/8

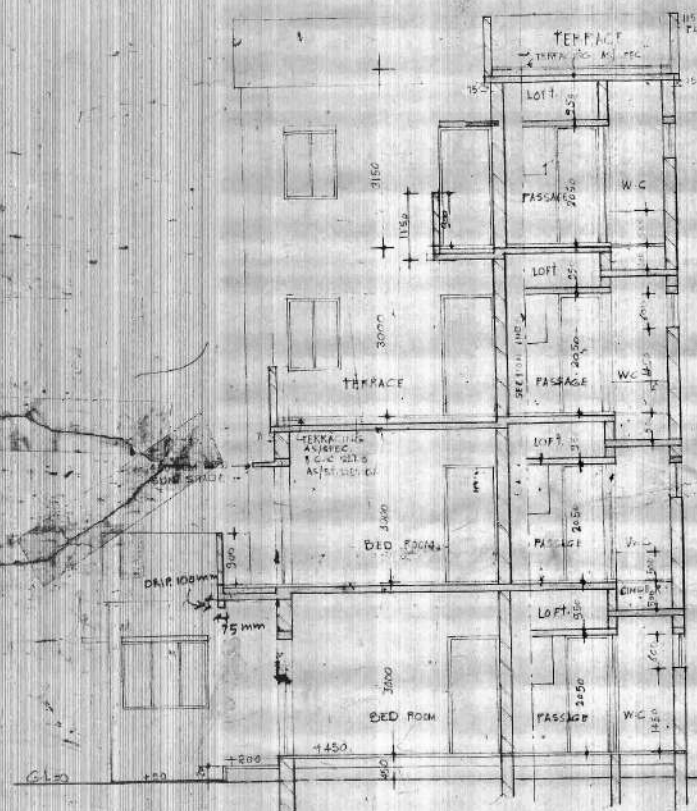

SECTION 'BB'

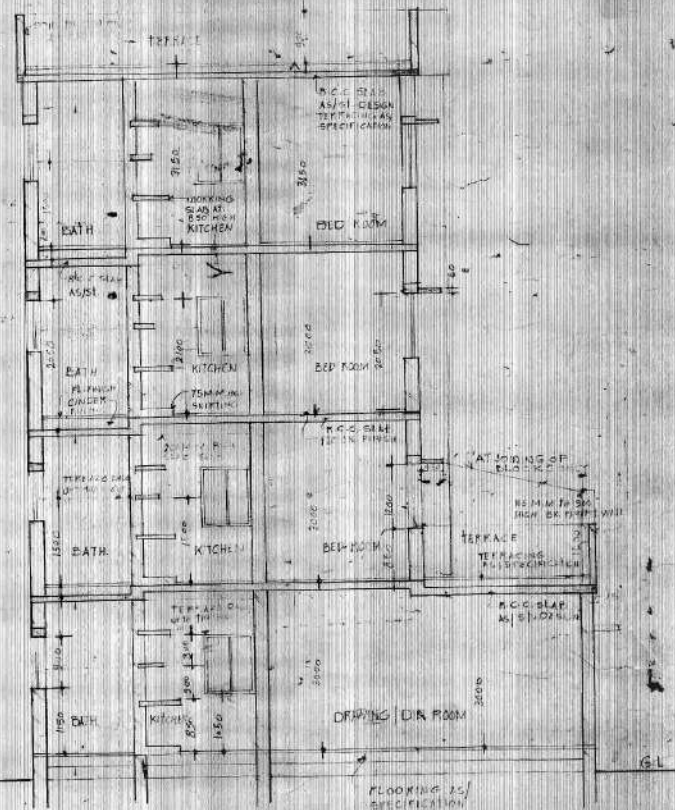

STANDARD DESIGN FOR
M. G. HOUSING

SECTION'S 2 192

ASCH	D/UNIT	ASST. MGR.	ARCHITECT
------	--------	------------	-----------

Kharin	1940
--------	------